



COPY RIGHT OF THIS DRAWING BELONGS TO. M/S S.S. CONSULTANTS AND SHOULD NOT BE USED FOR ANY PURPOSE OTHER THAN SPECIFIED WITHOUT PRIOR PERMISSION.

North :

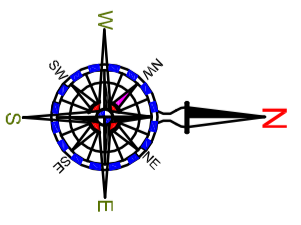

LEGEND :

- STORM WATER DRAIN =
- EXISTING MUNICIPAL DRAIN =
- HOME PIPE =

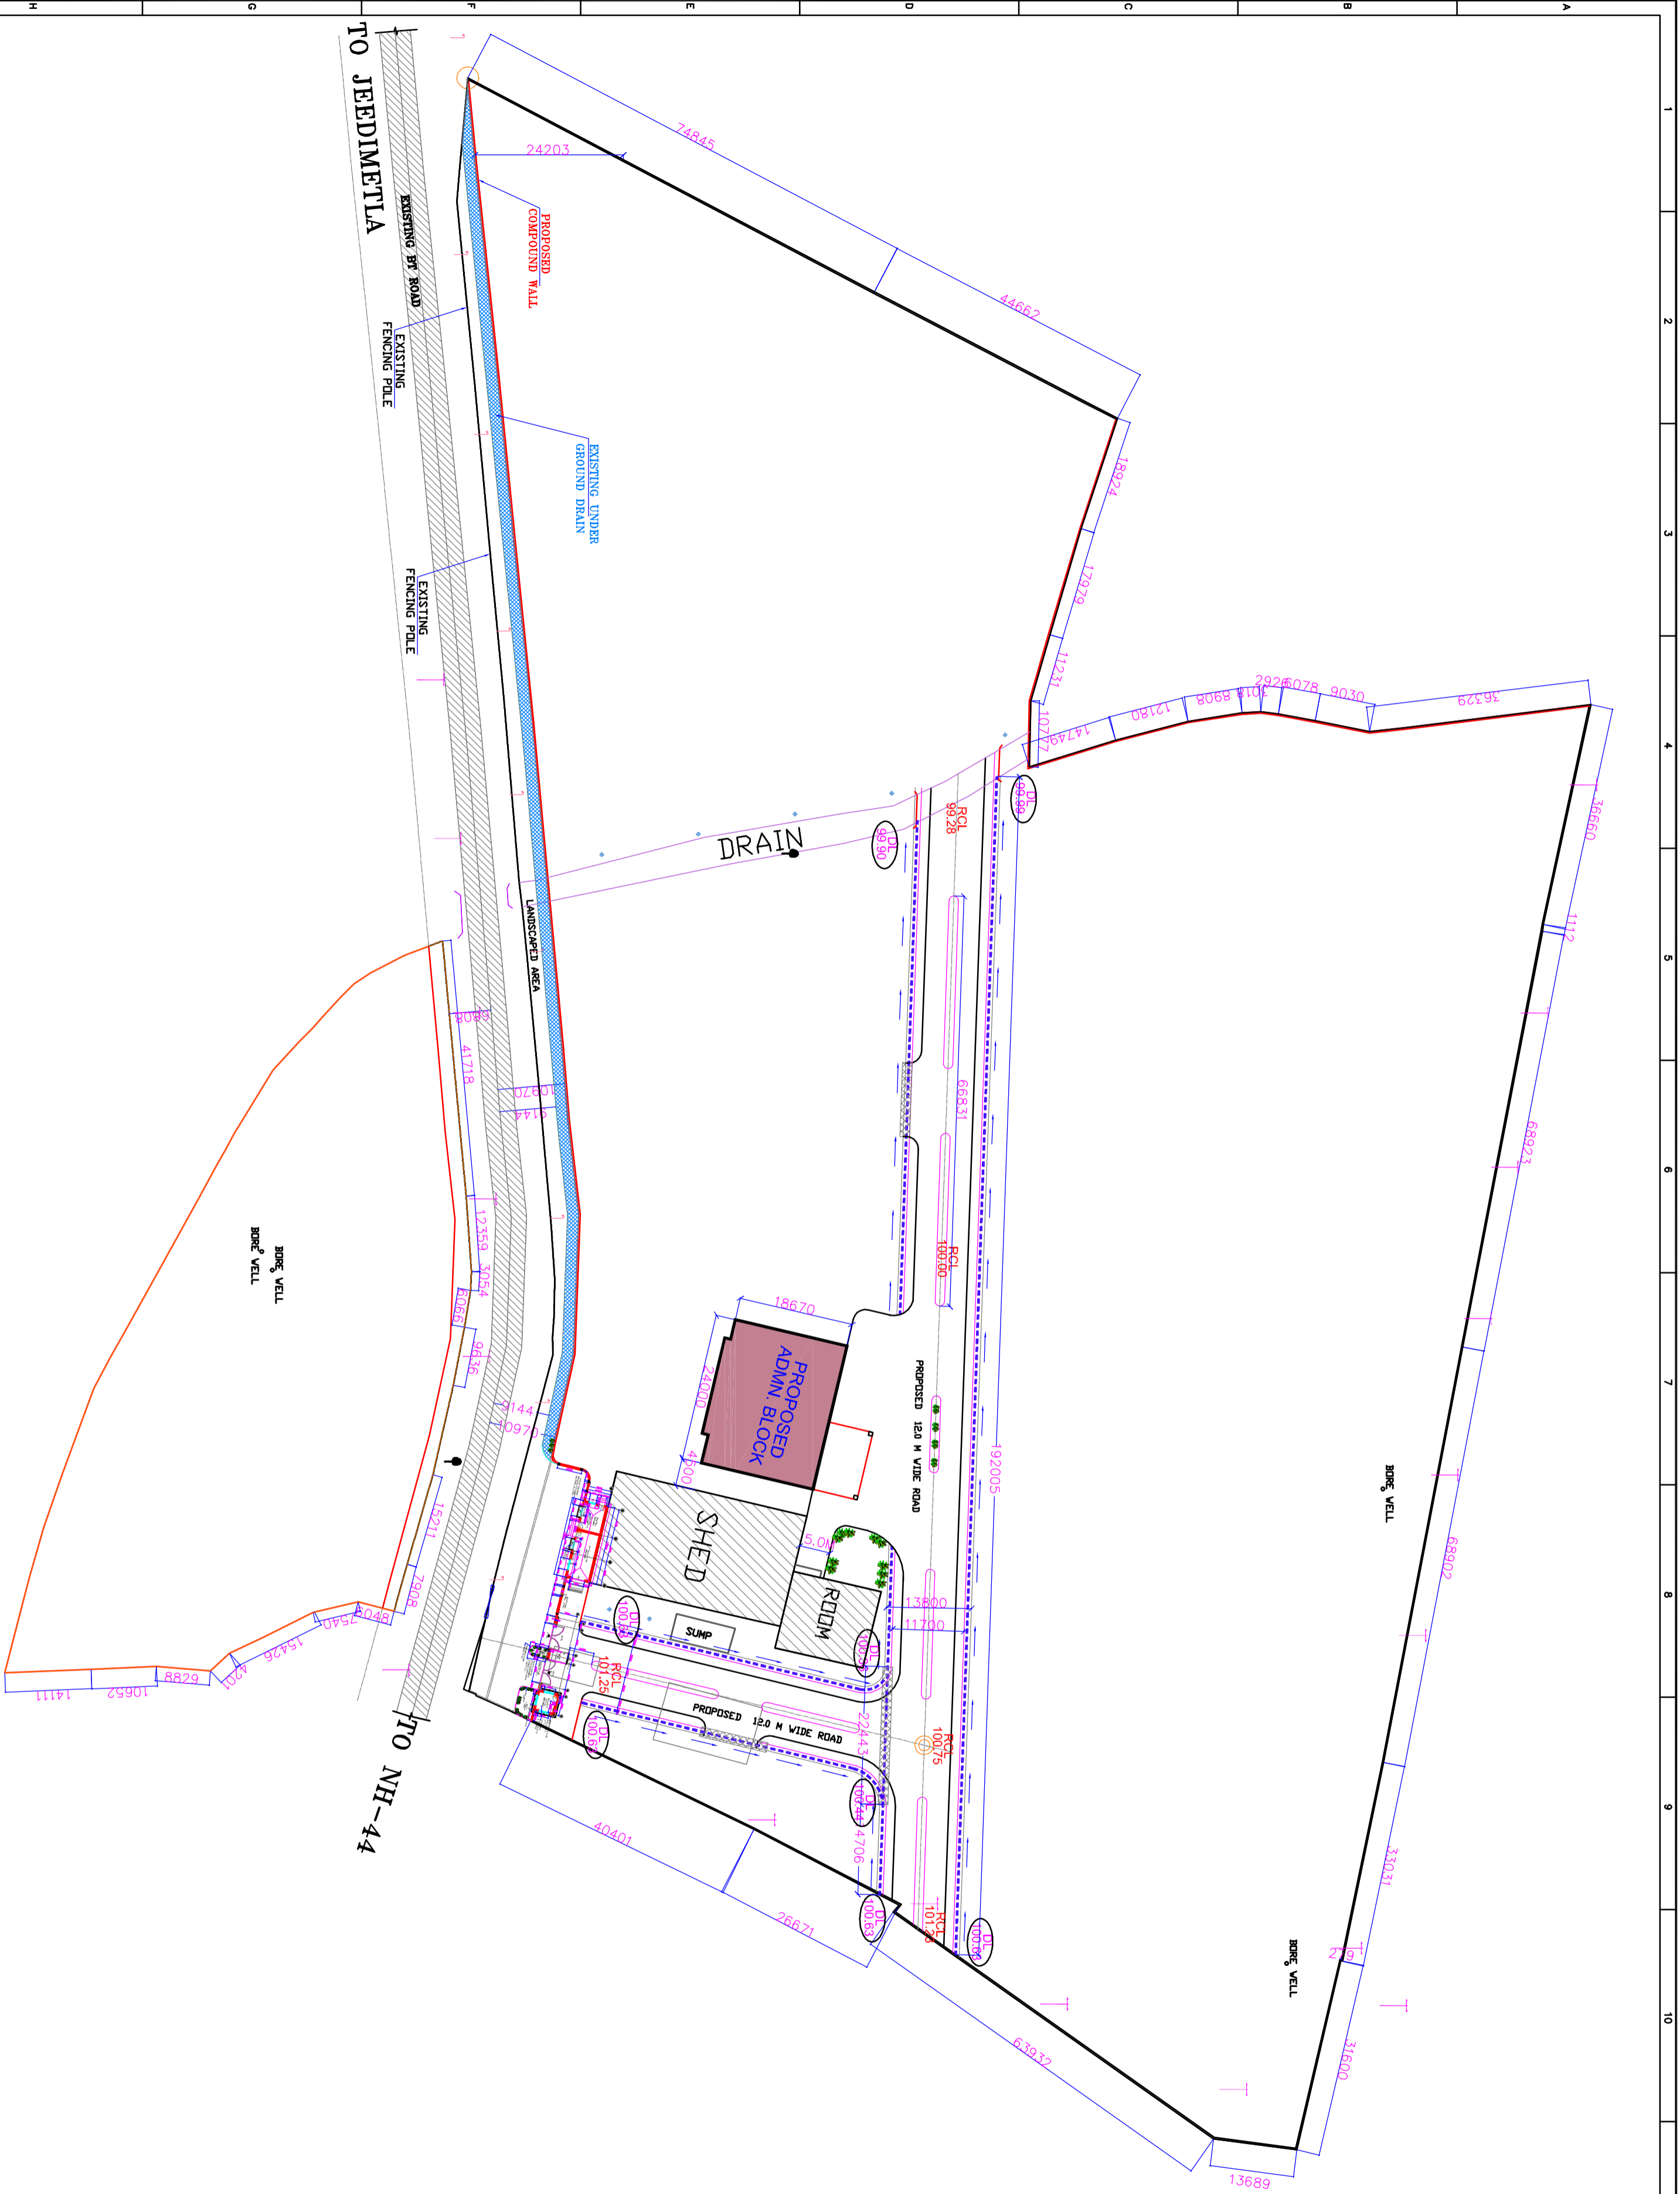

TO JEEDIMETLA

TO NH-44

SITE PLAN
LOCATION OF ADMIN. BLOCK

PROJECT :
PROPOSED ADMINISTRATION BLOCK
AT JEEDIMETLA HYDERABAD

CLIENT :
CENTRE OF EXCELLENCE
DEPT OF HORTICULTURE

CONSULTANTS :
S.S. CONSULTANTS

PROJECT CONSULTANTS
#1729, JABBAR BUILDINGS,
BEGLUPET, HYDERABAD-16
PH: 66310240, 66310954,
FAX NO: 040-66312949,
email: ssecns3599@gmail.com

DATE:	21.11.2015	SHEET NO:	01
SCALE:	N.T.S.		
DEALT BY:	DVNL		
DESIGNED BY:	B.V. RAMANA		
CHECKED BY:	S.S. RAO		

DRG. NO: SS/ HORT/ CENTRE OF EXCELLO. ADMIN/ AD-01